


T-1 TITLE SHEET, GENERAL NOTES
T-2 ANSI STANDARDS AND NOTES
A-1 EXISTING FLOOR PLANS
A-2 EAST AND WEST ELEVATIONS
A-3 NORTH AND SOUTHER ELEVATIONS
A-4 FOUNDATION PLAN AND DETAILS
A-5 BASEMENT PLAN AND DETAILS
A-6 FIRST FLOOR PLAN AND DETAILS
A-7 SECOND FLOOR PLAN AND DETAILS
A-8 ROOF PLAN AND DETAILS
A-9 SECTIONS AND DETAILS
A-10 CONSTRUCTION DETAILS
A-11 CONSTRUCTION DETAILS
A-12 DOOR AND WINDOWS TYPES,
NOTES AND DETAILS
MEP-1 BASEMENT ELECTRIC PLAN
MEP-2 FIRST FLOOR ELECTRIC PLAN
MEP-3 SECOND FLOOR ELECTRIC PLAN
MEP-4 PLUMBING RISER DIAGRAM
FS-1 FIRE SAFETY PLANS AND NOTES

3	REVISED AS PER BLDG. DPMT. ENG. COMMENTS 10-16-2
2	REVISED AS PER A.R.B. COMMENTS 10-4-23
1	REVISED AS PER A.R.B. COMMENTS 8-30-23
REVISION	

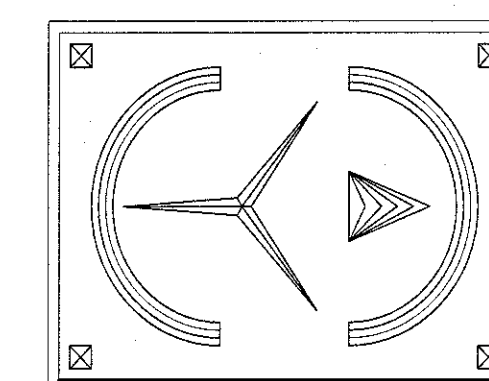

ERIC KNUTE OSBORN
ARCHITECT
RESIDENTIAL - COMMERCIAL - ADDITIONS
58 BARNES ROAD
WASHINGTONVILLE, N.Y. 10992 (845) 629-7474
EMAIL - EKOSBORNARCHITECT@GMAIL.COM
N.Y. LIC. #021-585

BNEI TORAH
SYNAGOGUE


62 RIVERGLEN DRIVE
THIELLS, N.Y. 10984

EAST AND WEST ELEVATIONS

START DATE:	3-31-23
ISSUE FOR BLDG DPMT PERMIT	7-03-23

A-2


SEAL & SIGNATURE
I HEREBY CERTIFY THAT TO THE BEST OF MY KNOWLEDGE, INFORMATION AND BELIEF, THESE PLANS AND SPECIFICATIONS ARE IN ACCORDANCE WITH THE APPLICABLE STANDARDS.

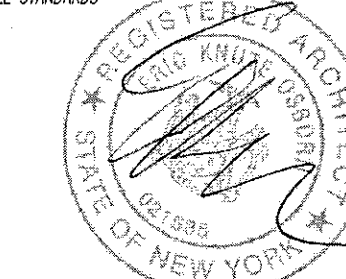

ERIC KNU/TE OSBORN, R.A. N.Y.S. NO. 021585 10-16-23



EAST ELEVATION - FRONT
SCALE : 1/4"=1'-0"

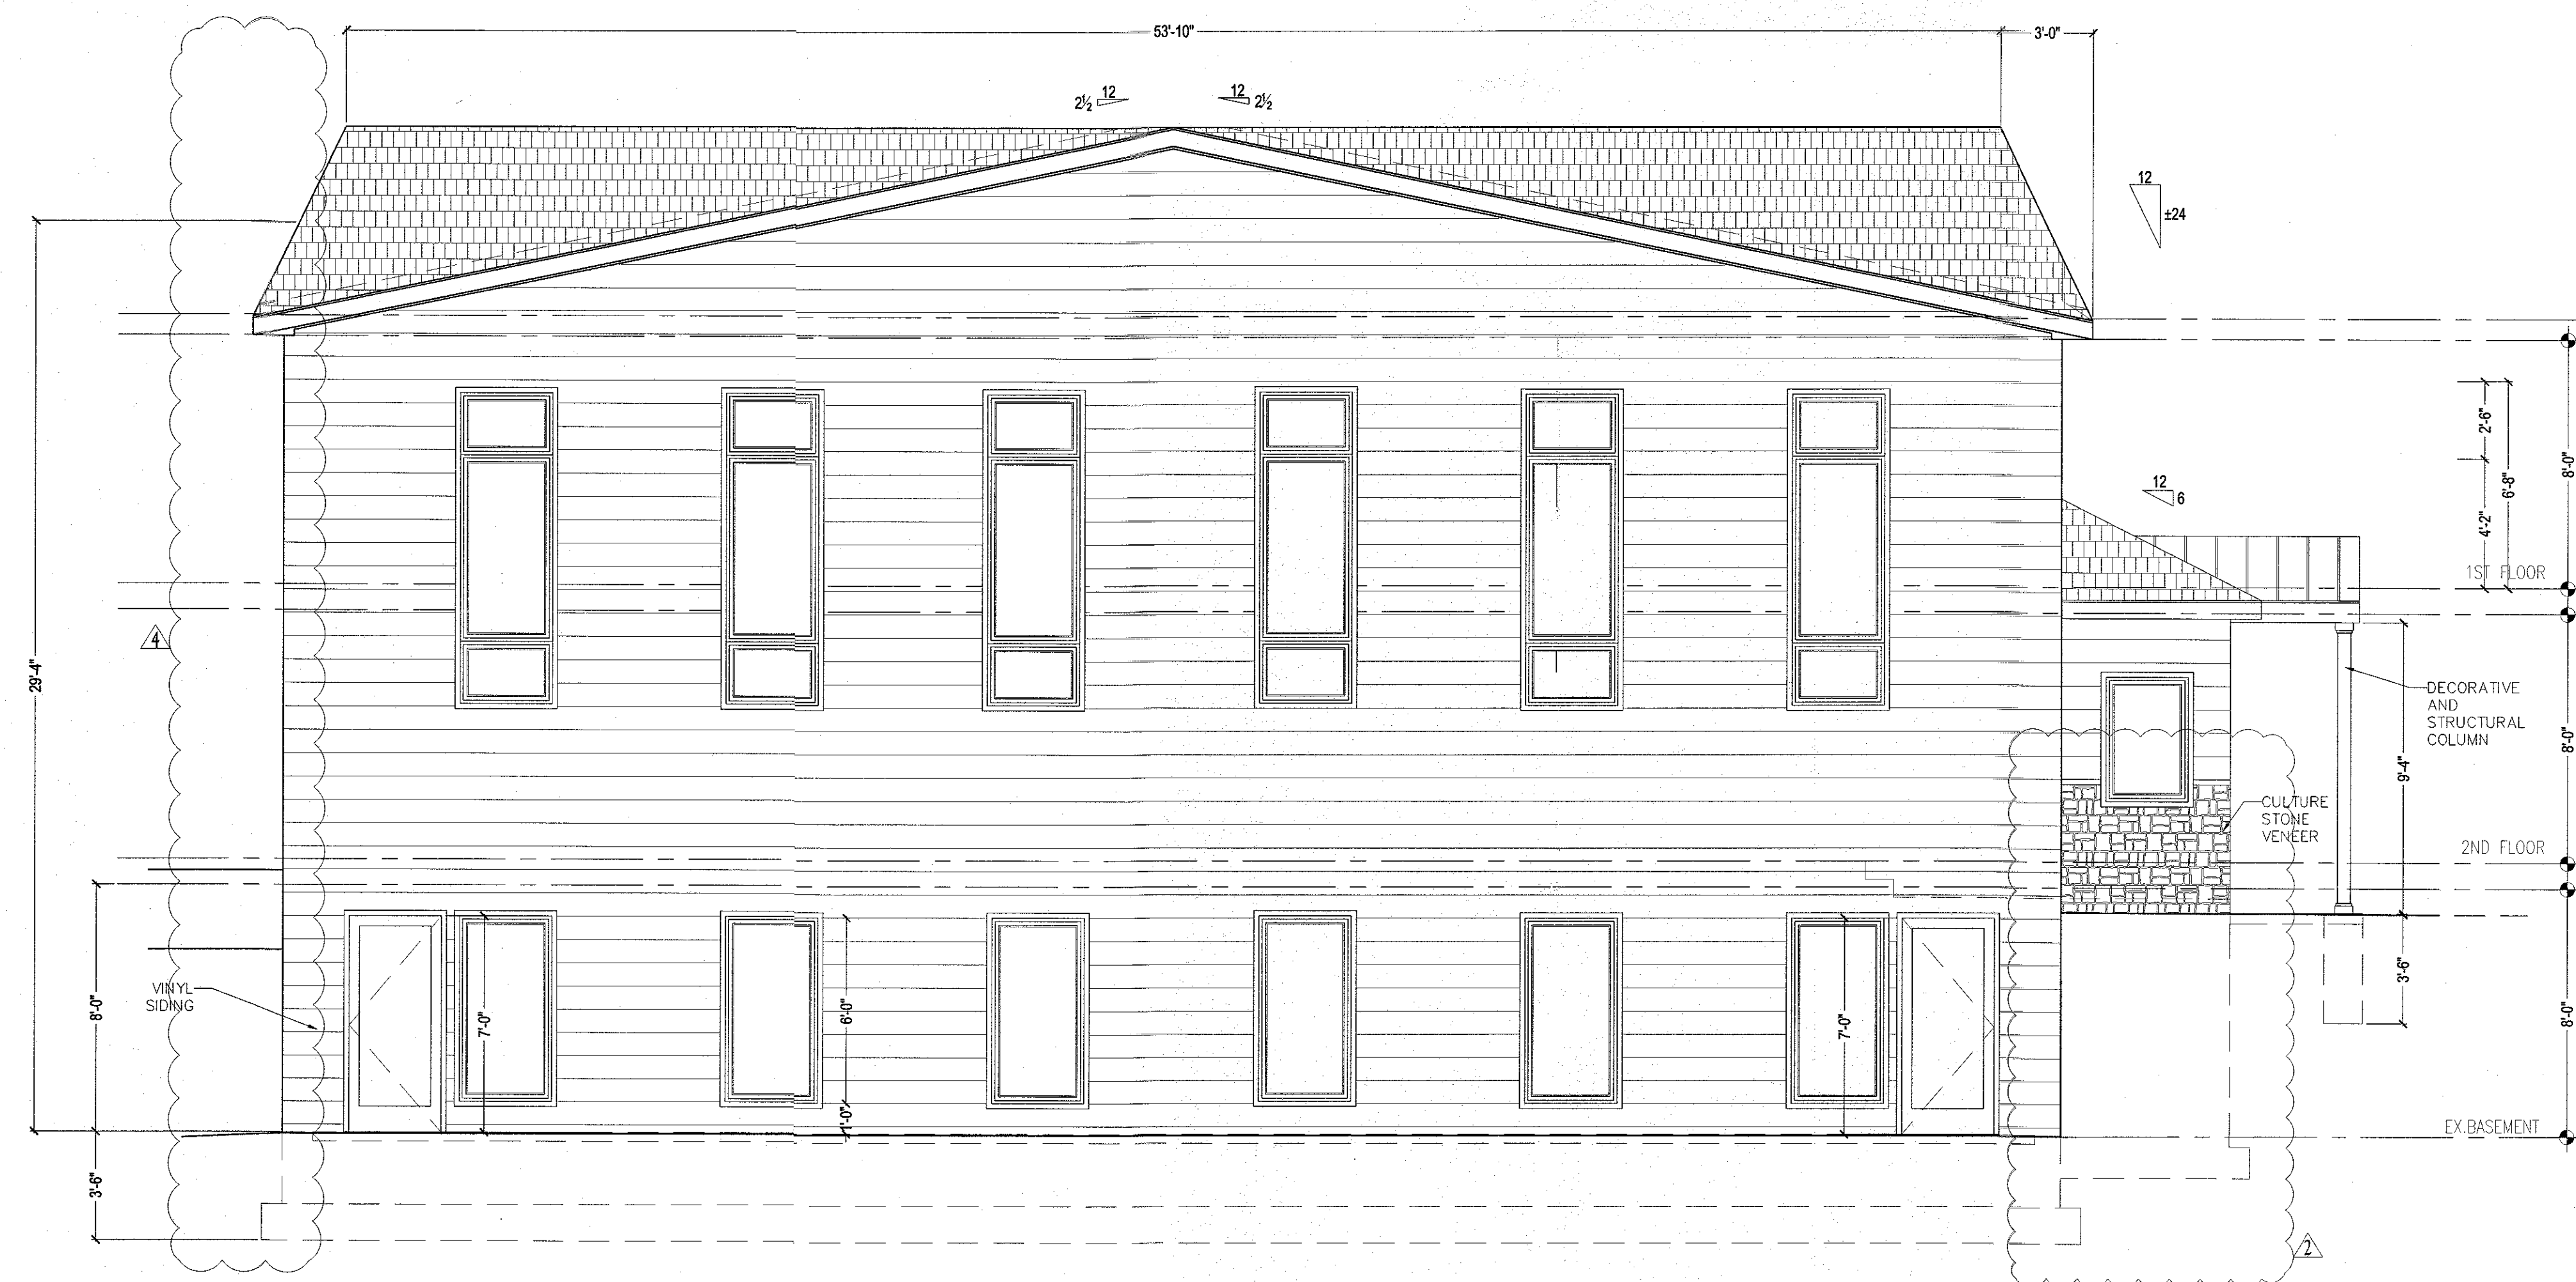


WEST ELEVATION - REAR
SCALE: 1/4"=1'-0"

NOTE - ARCHITECT ASSUMES NO LIABILITY FOR EXISTING STRUCTURE AND/OR CODE COMPLIANCE

DWG. LIST

T-1 TITLE SHEET, GENERAL NOTES AND
T-2 ANNOTATIONS AND NOTES
A-1 EXISTING AND PROPOSED DIMENSIONS
A-2 EXISTING AND PROPOSED ELEVATIONS
A-3 EXISTING AND PROPOSED DETAILS
A-4 EXISTING AND PROPOSED DETAILS
A-5 EXISTING AND PROPOSED DETAILS
A-6 EXISTING AND PROPOSED DETAILS
A-7 EXISTING AND PROPOSED DETAILS
A-8 EXISTING AND PROPOSED DETAILS
A-9 EXISTING AND PROPOSED DETAILS
A-10 CONSTRUCTION DETAILS
A-11 CONSTRUCTION DETAILS
A-12 DOOR AND WINDOWS TYPES,
NOTES AND DETAILS
MEP-1 BASEMENT ELECTRIC PLAN
MEP-2 FIRST FLOOR ELECTRIC PLAN
MEP-3 SECOND FLOOR ELECTRIC PLAN
MEP-4 PLUMBING RISER DIAGRAM
FS-1 FIRE SAFETY PLANS AND NOTES

REVISD AS PER BLDG DPMT ENG COMMENTS 10-16-21
REVISD AS PER A.R.B. COMMENTS 10-4-23
REVISD AS PER A.R.B. COMMENTS 8-30-23
REVISION

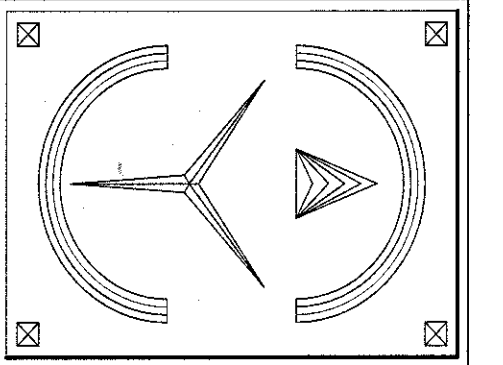

**ERIC KNUTE OSBORN
ARCHITECT**

RESIDENTIAL - COMMERCIAL - ADDITIONS
58 BARNES ROAD
WASHINGTONVILLE, N.Y. 10990-1845 (845) 629-7474
EMAIL: EKOSBORNARCHITECT@GMAIL.COM
N.Y. LIC. #0211585

PROJECT

**BNEI TORAH
SYNAGOGUE**

62 RIVERGLEN DRIVE
THIELLS, N.Y. 10984

**NORTH AND SOUTH
ELEVATIONS**

PLAN DATA

START DATE: 3-31-23
ISSUE FOR BLDG DPMT PERMIT 7-03-23

SCALE: AS NOTED


DWG. No.

A-3

SEAL & SIGNATURE
I HEREBY CERTIFY THAT TO THE BEST OF MY KNOWLEDGE, INFORMATION AND BELIEF, THESE PLANS AND SPECIFICATIONS ARE IN ACCORDANCE WITH THE APPLICABLE STANDARDS



ERIC KNUTE OSBORN, P.A. N.Y.S. NO. 0211585 89-166-223

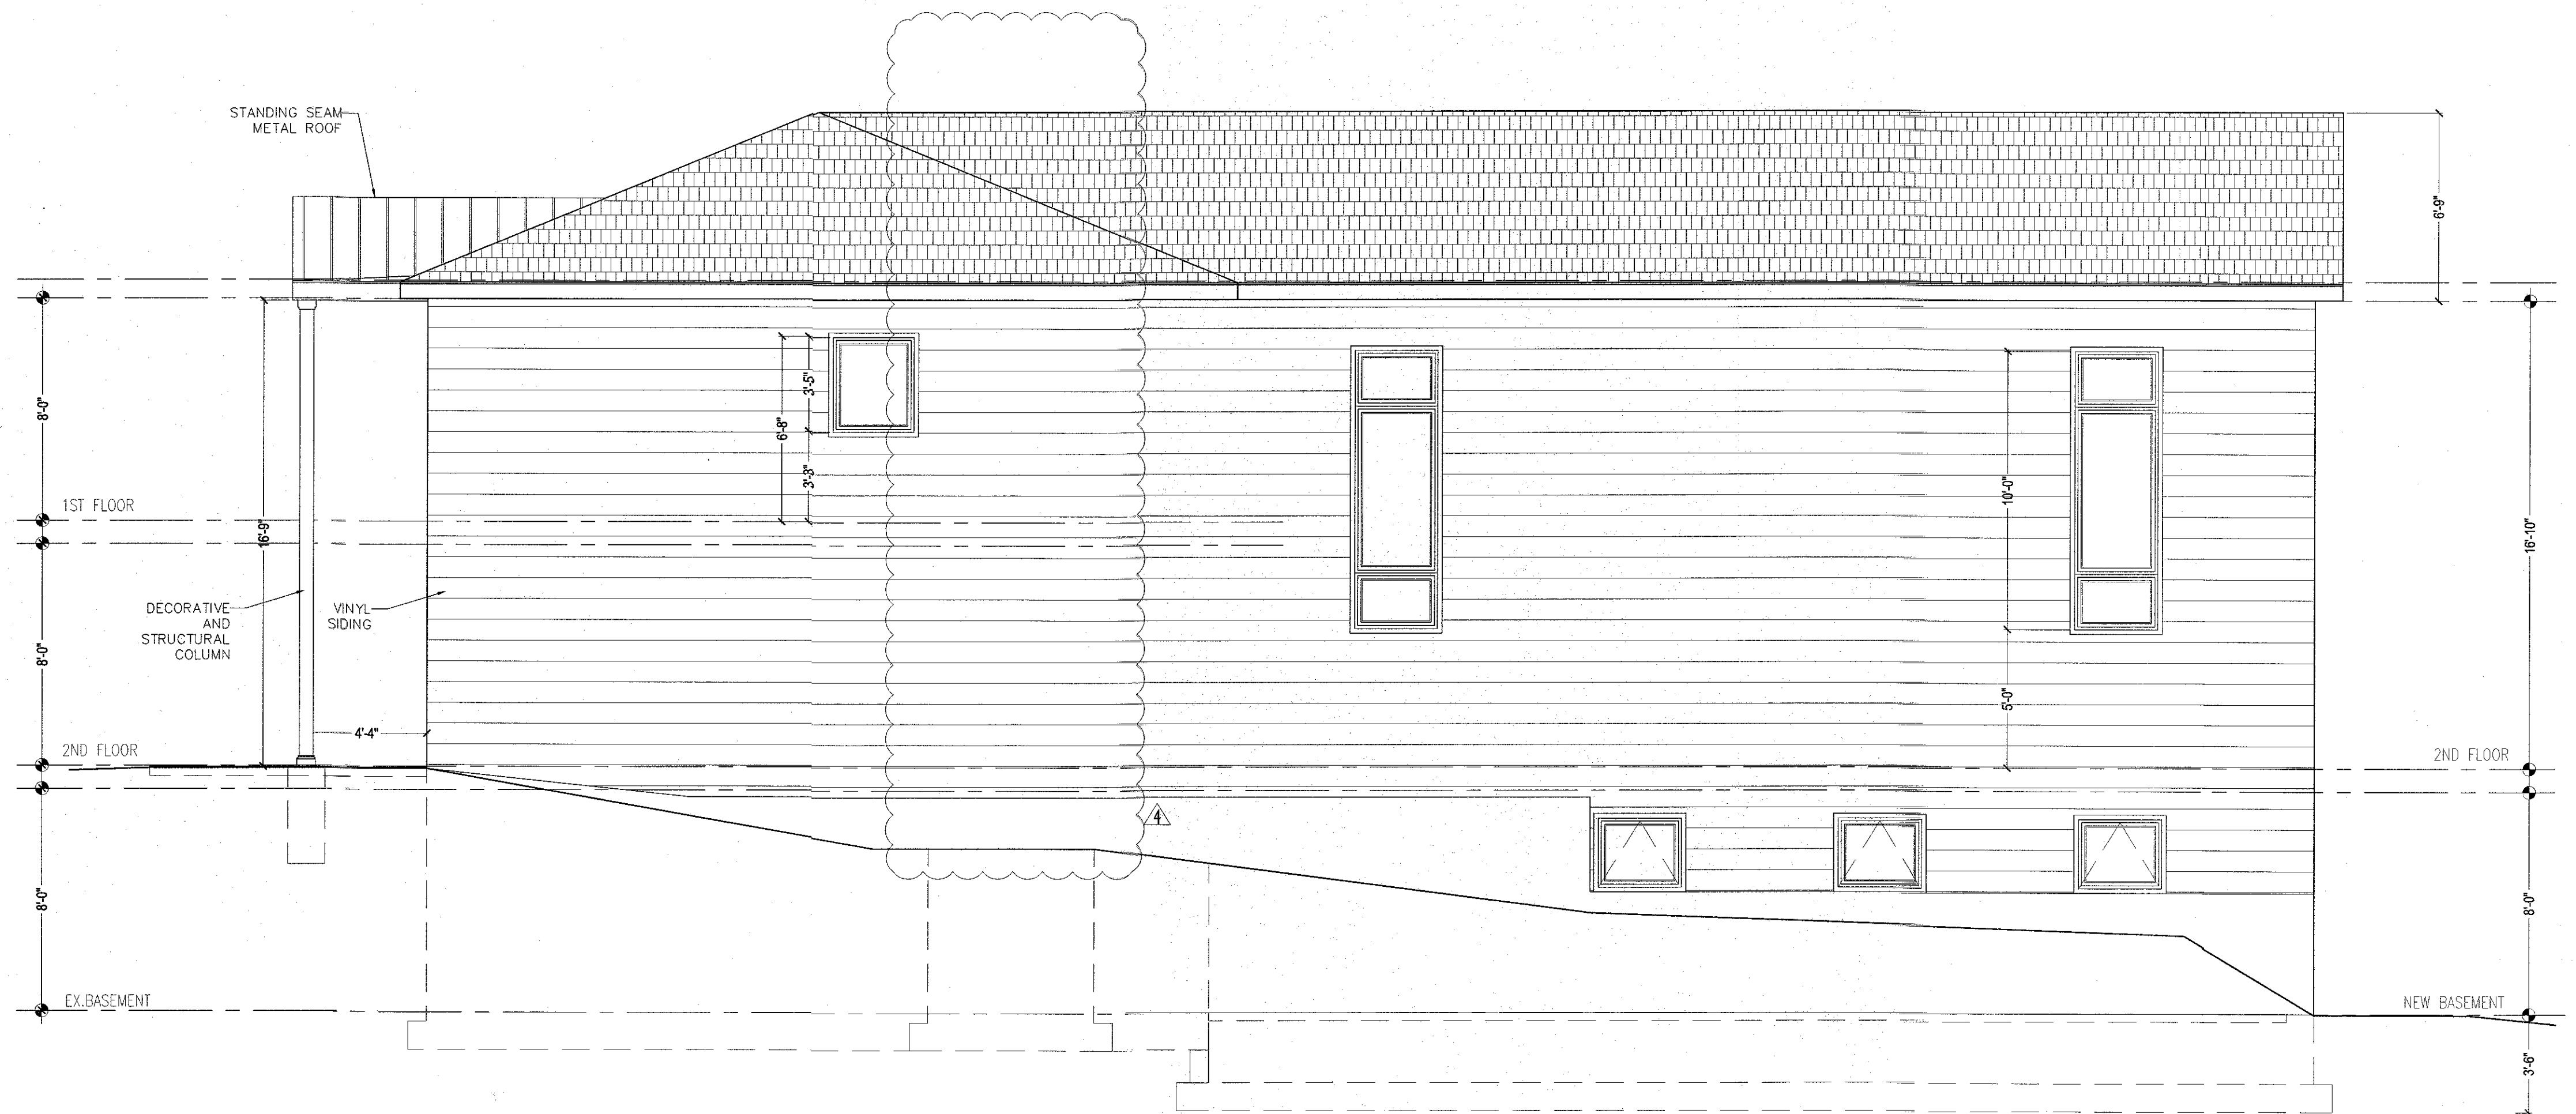

NORTH ELEVATION - RIGHT

SCALE: 1/4"=1'-0"



SOUTH ELEVATION - LEFT

SCALE: 1/4"=1'-0"

NOTE: ARCHITECT ASSUMES NO LIABILITY FOR EXISTING STRUCTURE AND/OR CODE COMPLIANCE